

EAST COUNTY HALL OF JUSTICE
 Courts Building - 5151 Gleason Dr.
 County Building - 5149 Gleason Dr.
 Dublin, CA 94568



NO.	ISSUED FOR	DATE
1	DP-3	10/22/2014
2	50_CD	12/02/2014
5	DP-4	02/10/2015
6	DP-4_ADD C	04/07/2015
6	DP-4_RESP 1	05/21/2015
7	PROJECT RECORD DRAWINGS	04/17/2017

STAMP

DRAWING TITLE
 ENLARGED PLUMBING PLAN
 LE-EL-1-AREA B
 PROJECT # 20130014.001
 CS/SM 01-01-11-0005
 SHEET NUMBER
P2213

NOTE:
 ALL LISTED SHEET NOTES MAY NOT BE USED ON EVERY SHEET.
 UNDERFLOOR PLUMBING SHOWN FADED FOR REFERENCE P.O.C.'S.

- | | |
|------------------------|---------------------|
| 1 2" W | 51 1-1/4" CW |
| 2 2" W DN | 52 1-1/4" CW FB |
| 3 2" W FA | 53 1-1/4" CW TA |
| 4 2" P-TRAP | 54 1-1/4" HW |
| 5 3" W | 55 1-1/4" HW FB |
| 6 3" W DN | 56 1-1/4" HW TA |
| 7 3" W FA | 57 1-1/4" HWR |
| 8 3" P-TRAP | 58 1-1/2" CW |
| 9 4" W | 59 1-1/2" CW FB |
| 10 4" W DN | 60 1-1/2" CW TA |
| 11 4" W FA | 61 1-1/2" HW |
| 12 4" P-TRAP | 62 1-1/2" HW FB |
| 13 4" DEEP SEAL P-TRAP | 63 1-1/2" HW TA |
| 14 FIXTURE CARRIER | 64 1-1/2" HWR |
| 15 1-1/2" V | 65 2" CW |
| 16 1-1/2" V UP | 66 2" CW FB |
| 17 2" V | 67 2" CW TA |
| 18 2" V FB | 68 2" HW |
| 19 2" V TA | 69 2" HW FB |
| 20 2" VTR | 70 2" HW TA |
| 21 3" V | 71 2" HWR |
| 22 3" V FB | 72 2-1/2" CW |
| 23 3" V TA | 73 2-1/2" CW FB |
| 24 3" VTR | 74 2-1/2" CW TA |
| 25 4" V | 75 2-1/2" HW |
| 26 4" V FB | 76 2-1/2" HW FB |
| 27 4" V TA | 77 2-1/2" HW TA |
| 28 4" VTR | 78 2-1/2" HWR |
| 29 1/2" H & C | 79 3" CW |
| 30 1/2" CW | 80 3" CW FB |
| 31 1/2" CW FB | 81 3" CW TA |
| 32 1/2" CW TA | 82 3" HW |
| 33 1/2" HW | 83 3" HW FB |
| 34 1/2" HW FB | 84 3" HW TA |
| 35 1/2" HW TA | 85 4" CW |
| 36 1/2" HWR | 86 4" CW FB |
| 37 3/4" CW | 87 4" CW TA |
| 38 3/4" CW FB | 88 1/2" SOV |
| 39 3/4" CW TA | 89 3/4" SOV |
| 40 3/4" HW | 90 1" SOV |
| 41 3/4" HW FB | 91 1-1/4" SOV |
| 42 3/4" HW TA | 92 1-1/2" SOV |
| 43 3/4" HWR | 93 2" SOV |
| 44 1" CW | 94 2-1/2" SOV |
| 45 1" CW FB | 95 3" SOV |
| 46 1" CW TA | 96 4" SOV |
| 47 1" HW | 97 H&C CONTROL ASSY |
| 48 1" HW FB | 98 1/2" TRAP PRIMER |
| 49 1" HW TA | 99 1-1/4" ICW |
| 50 1" HWR | 100 |

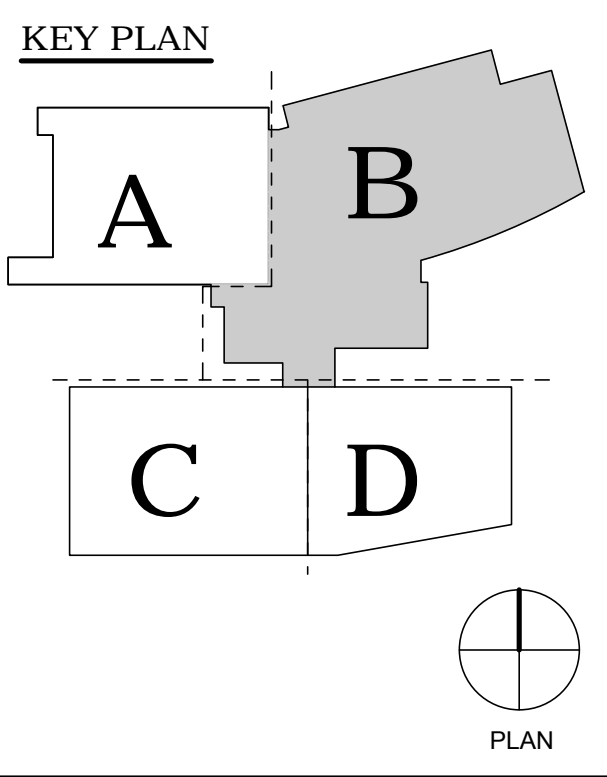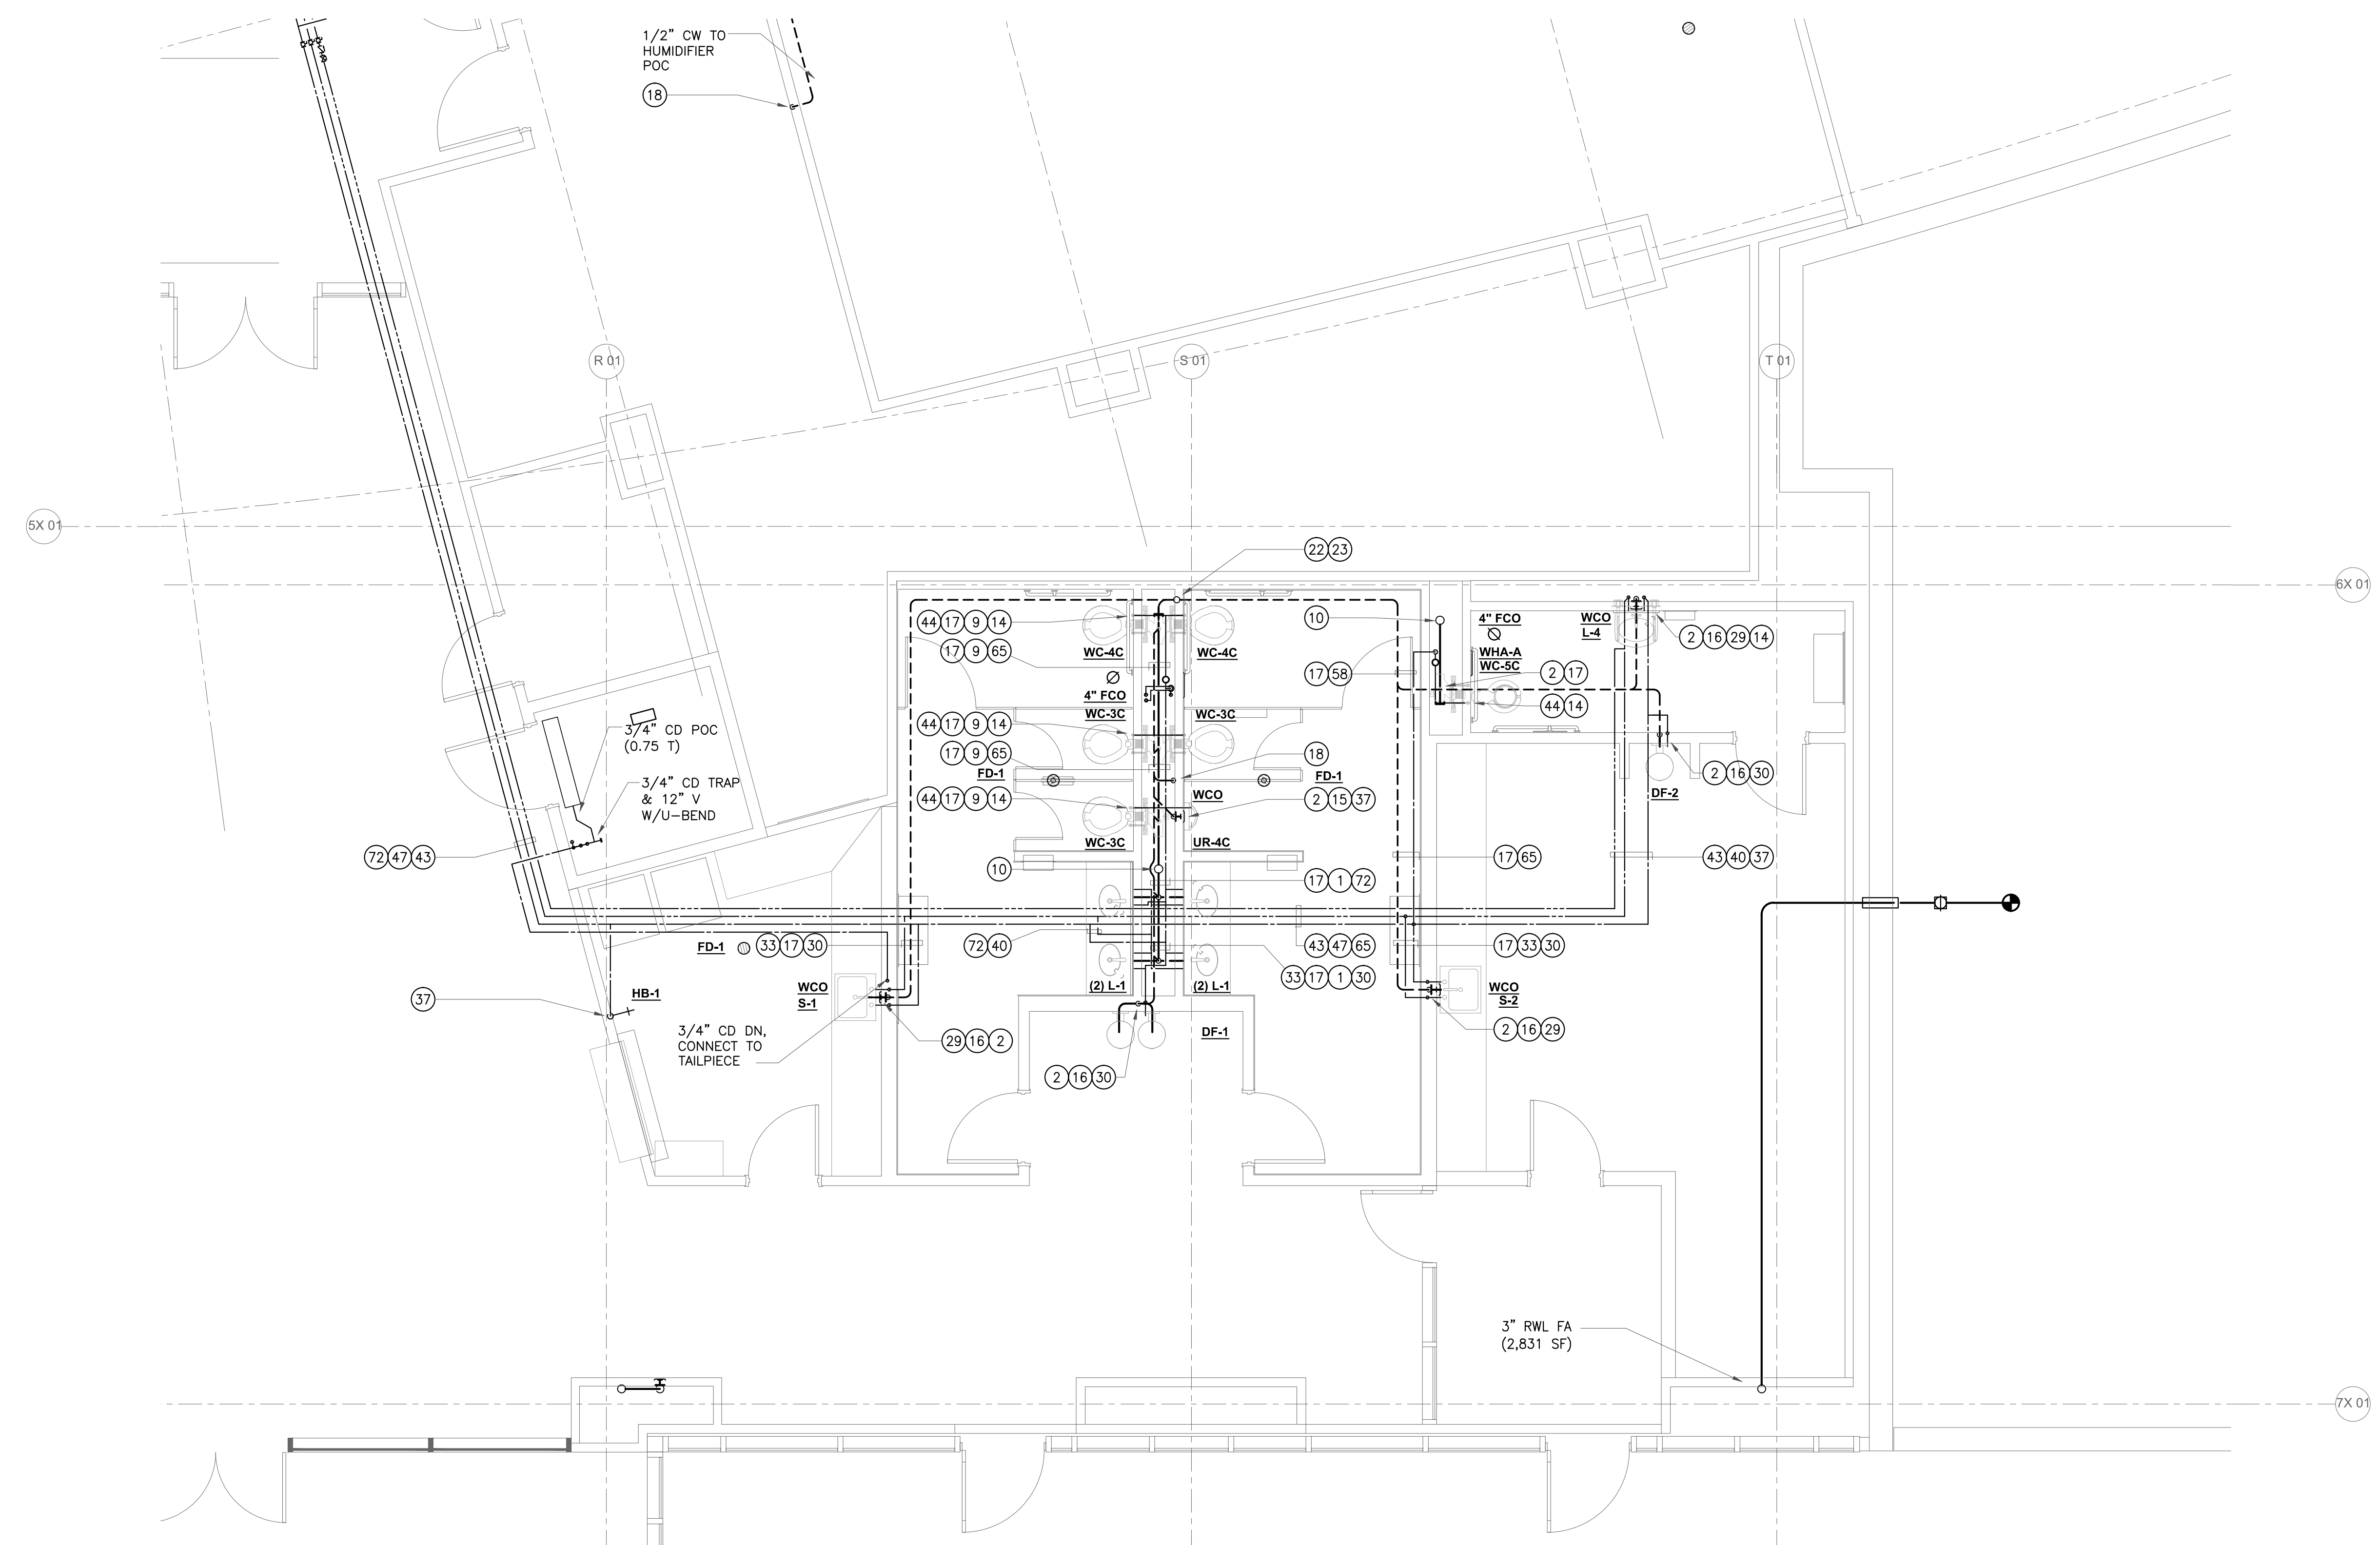

1 ENLARGED PLUMBING PLAN - 1B105, 1B104, 1B115, 1B121

SCALE: 1/4" = 1'-0"